



Miller & Associates
 Consulting Engineers, P.C.
 Kearney, NE (308) 234-6486
 McCook, NE (308) 245-3710

NEBRASKA YOUTH CAMP
FLOOR PLAN
 KEARNEY, NEBRASKA

The documents, and the ideas and designs incorporated therein, are an instrument of professional service, in the property of Miller & Associates and is not to be used in whole or in part, for any other project without the written authorization of Miller & Associates.

VERIFY SCALES

BAR IS ONE INCH ON ORIGINAL DRAWING
 0" = 1"
 IF NOT ONE INCH ON THIS SHEET, ADJUST SCALES ACCORDINGLY.

SCALE: AS NOTED


PROJECT NO. 130-PTD-021-06

DATE: APRIL 2007

FIELD BOOK: NA M&A DWG NO.:

DRAWN BY: GCB APRVD BY:

SHEET 1

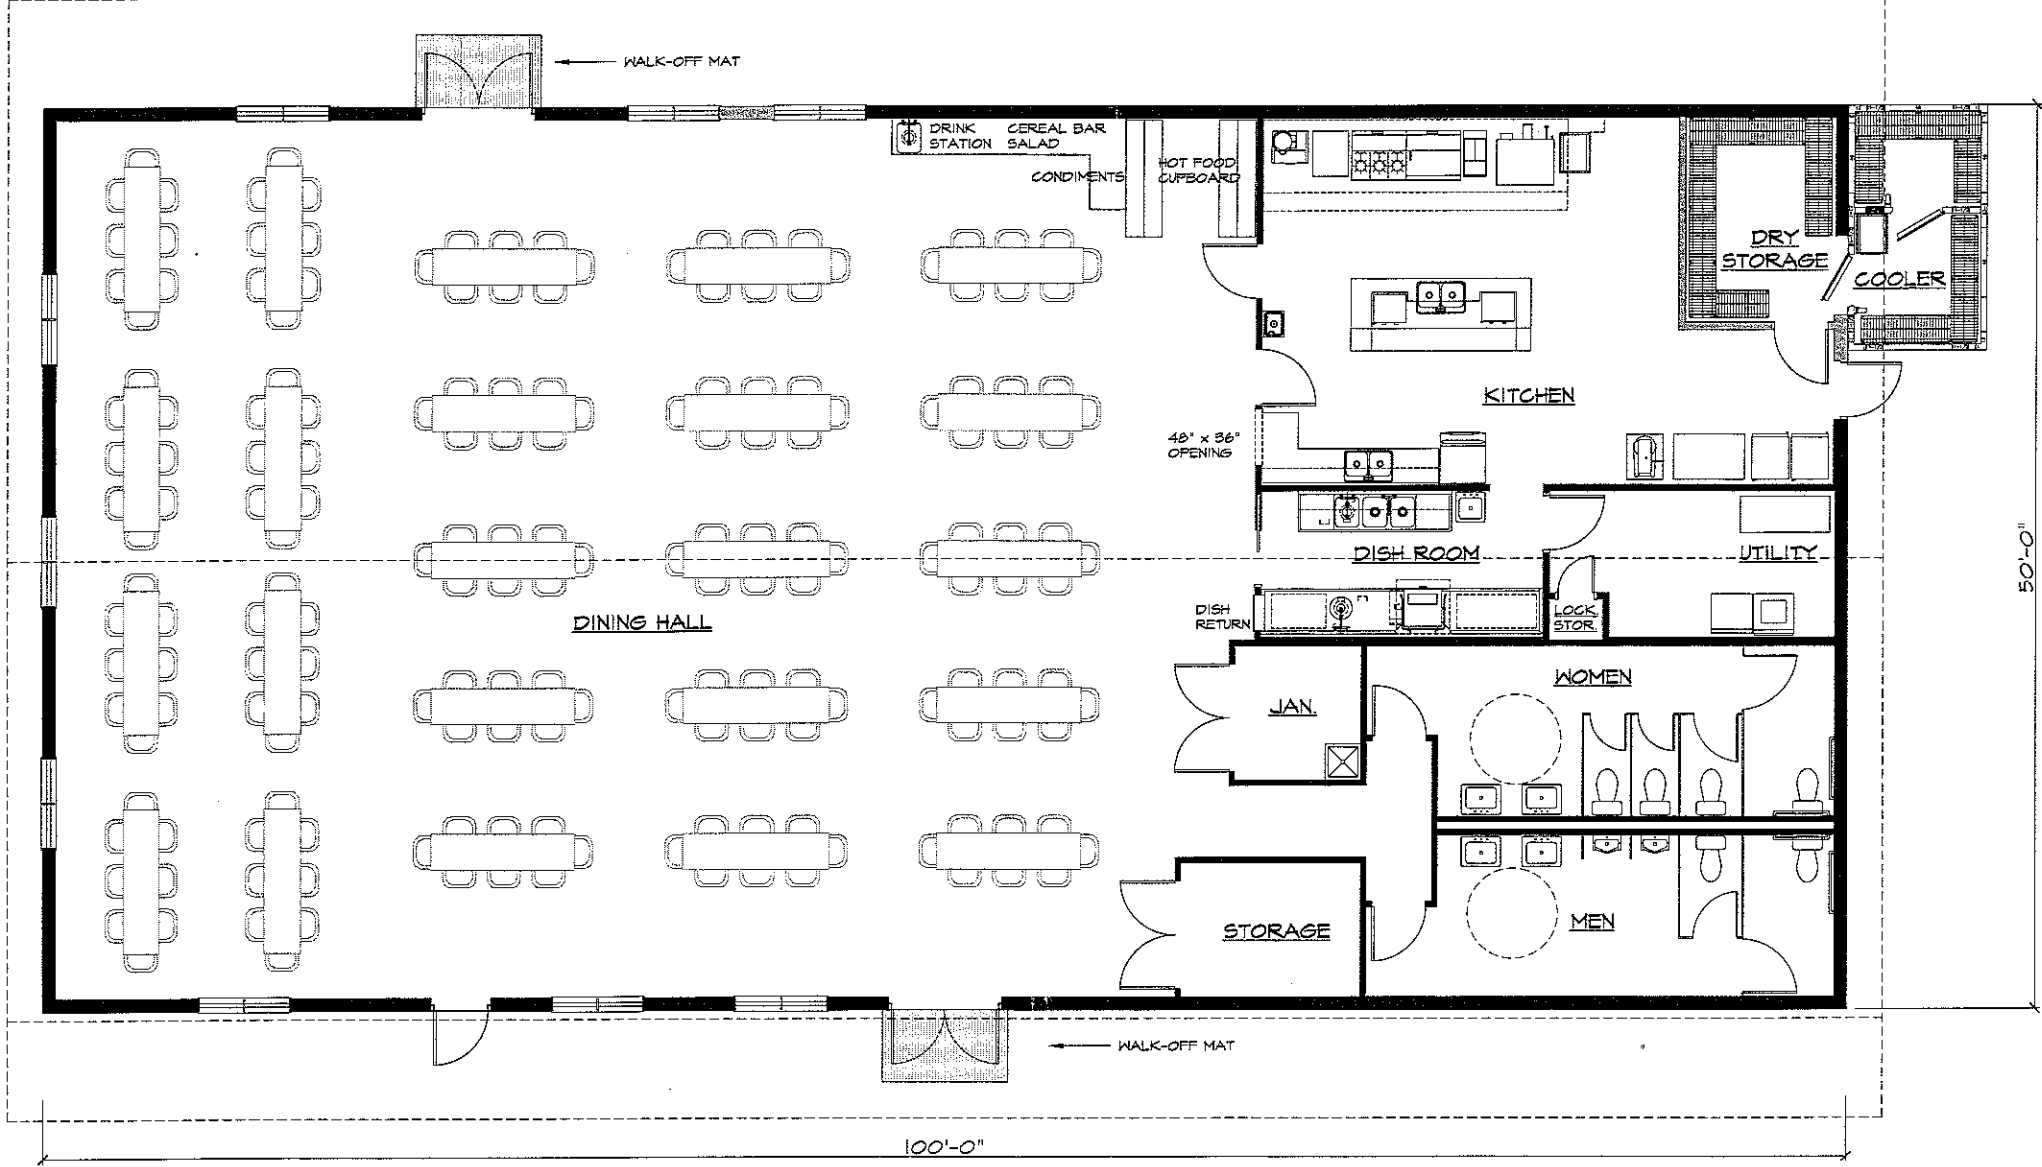

FLOOR PLAN

SCALE: 1/4" = 1'-0"

APR 12, 2007 1:18:24.5 Location: C:\projects\130-PTD-021-06\130-PTD-021-06.dwg Plot: 130-PTD-021-06.dwg